


Small Office - Enabled Fixtures With Daylighting

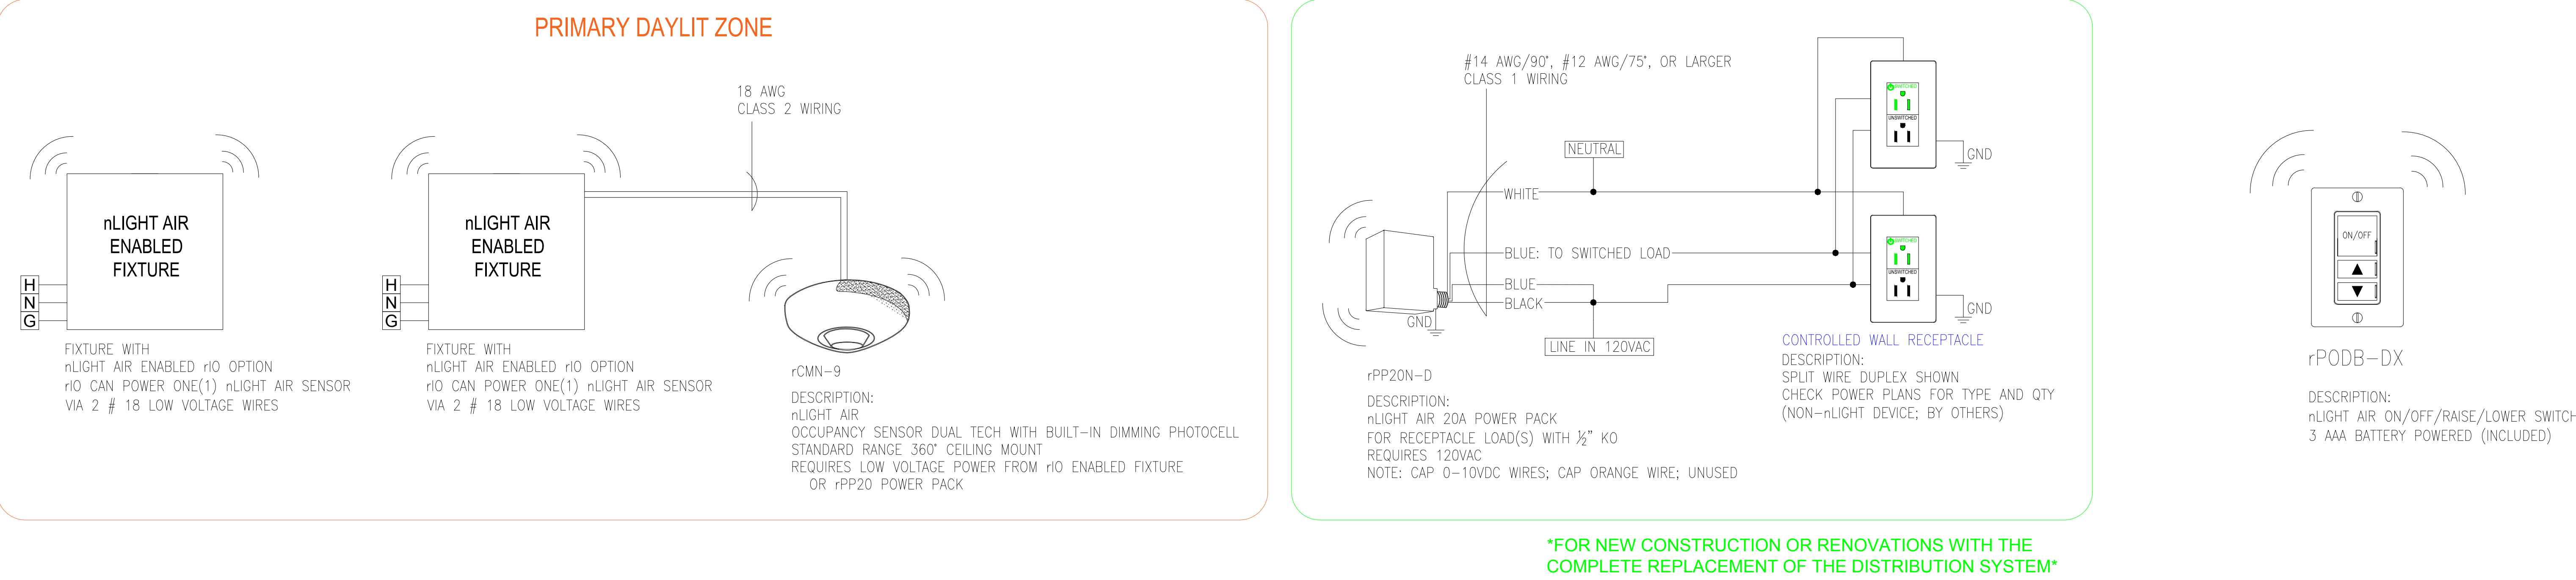

FOR NEW CONSTRUCTION OR RENOVATIONS WITH THE COMPLETE REPLACEMENT OF THE DISTRIBUTION SYSTEM

NTS

TYPICAL PRIVATE OFFICE WITH DAYLIGHTING USING nLIGHT ENABLED FIXTURES

REFER TO PLANS FOR TYPES AND QUANTITIES

T24 2016 COMPLIANT SEQUENCE OF OPERATION:

1. OCCUPANCY SENSOR PROVIDES PARTIAL ON TO 70% AND AUTOMATIC OFF OF LIGHTS AND CONTROLLED RECEPTACLES BASED ON ROOM OCCUPANCY (USE DEFAULT TIME DELAY FOR OCCUPANCY SENSOR) .
2. rPODB DX SWITCH PROVIDES MANUAL OVERRIDE OF THE LIGHTS: ON/OFF/RAISE/LOWER.

REV	DATE

Date: _____

Scale: NOT TO SCALE

Drawn By: _____

Project #: _____

DWG Ref: _____

Sheet: _____